



www.hbadesign.com

REVISIONS DATE


NINGBO VILLA  
CHINA

SECOND FLOOR  
LOW LEVEL LIGHTING LAYOUT

DRAWING TITLE  
DRAWN BY  
DATE 11/08/2011  
SCALE 1:100@A2

APPROVED  
DATE 11/08/2011  
SCALE 1:100@A2

SHEET No.  
LD1-2.1  
PROJECT No.  
2816.80

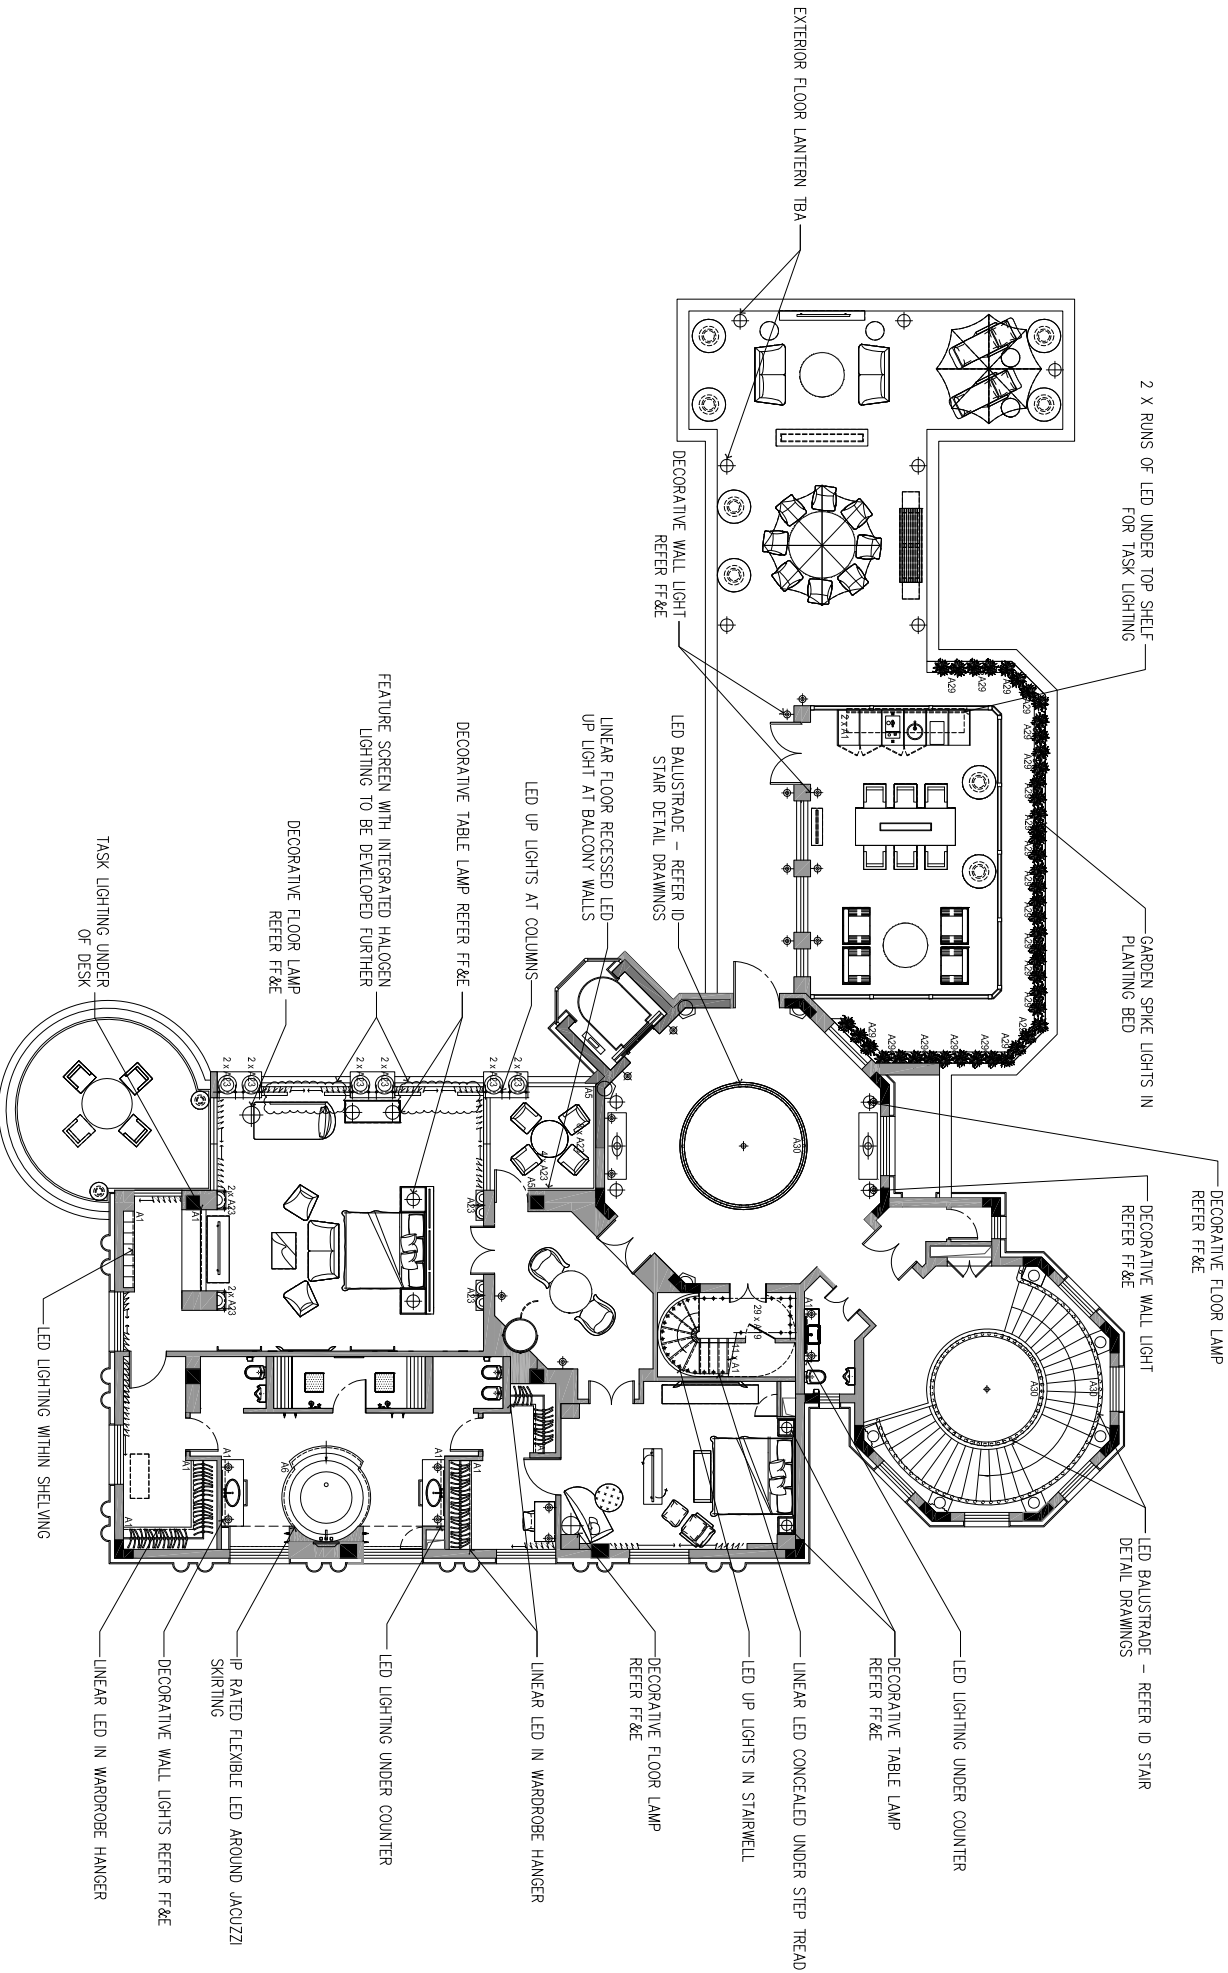

\*ALL ADJUSTABLE LIGHT  
FITTINGS AND LIGHTING  
SCENE LEVELS REQUIRE  
COMMISSIONING BY  
LIGHTING DESIGNER  
所有可调节的灯光和照明场景需要调试灯光设计师

2.1 SECOND FLOOR – LOW LEVEL LIGHTING LAYOUT  
Scale 1:100@A2

FOR INFORMATION  
DATE:11 AUGUST 2011