



www.hbadesign.com

NINGBO VILLA
CHINA

REVISIONS DATE


BASEMENT FLOOR
REFLECTED CEILING LIGHTING LAYOUT

DRAWING TITLE
BASED ON THE LATEST AVAILABLE INFORMATION
THIS DRAWING IS THE PROPERTY OF HBA
AND IS NOT TO BE REPRODUCED OR
TRANSMITTED IN ANY FORM OR BY ANY
MEANS, ELECTRONIC OR MECHANICAL,
INCLUDING PHOTOCOPYING, RECORDING,
OR BY ANY INFORMATION STORAGE AND
RETRIEVAL SYSTEM, WITHOUT THE
WRITTEN PERMISSION OF HBA.

APPROVED
DRAWN BY
DATE 11/08/2011
SCALE 1:100@A2

SHEET NO.
LD1-4.2
PROJECT NO.
2816.80

HIRSCH BEDNER ASSOCIATES ■ DESIGN CONSULTANTS ■ GROUND FLOOR 44 OXFORD ST. COLLINGWOOD,VIC AUSTRALIA +61394183500

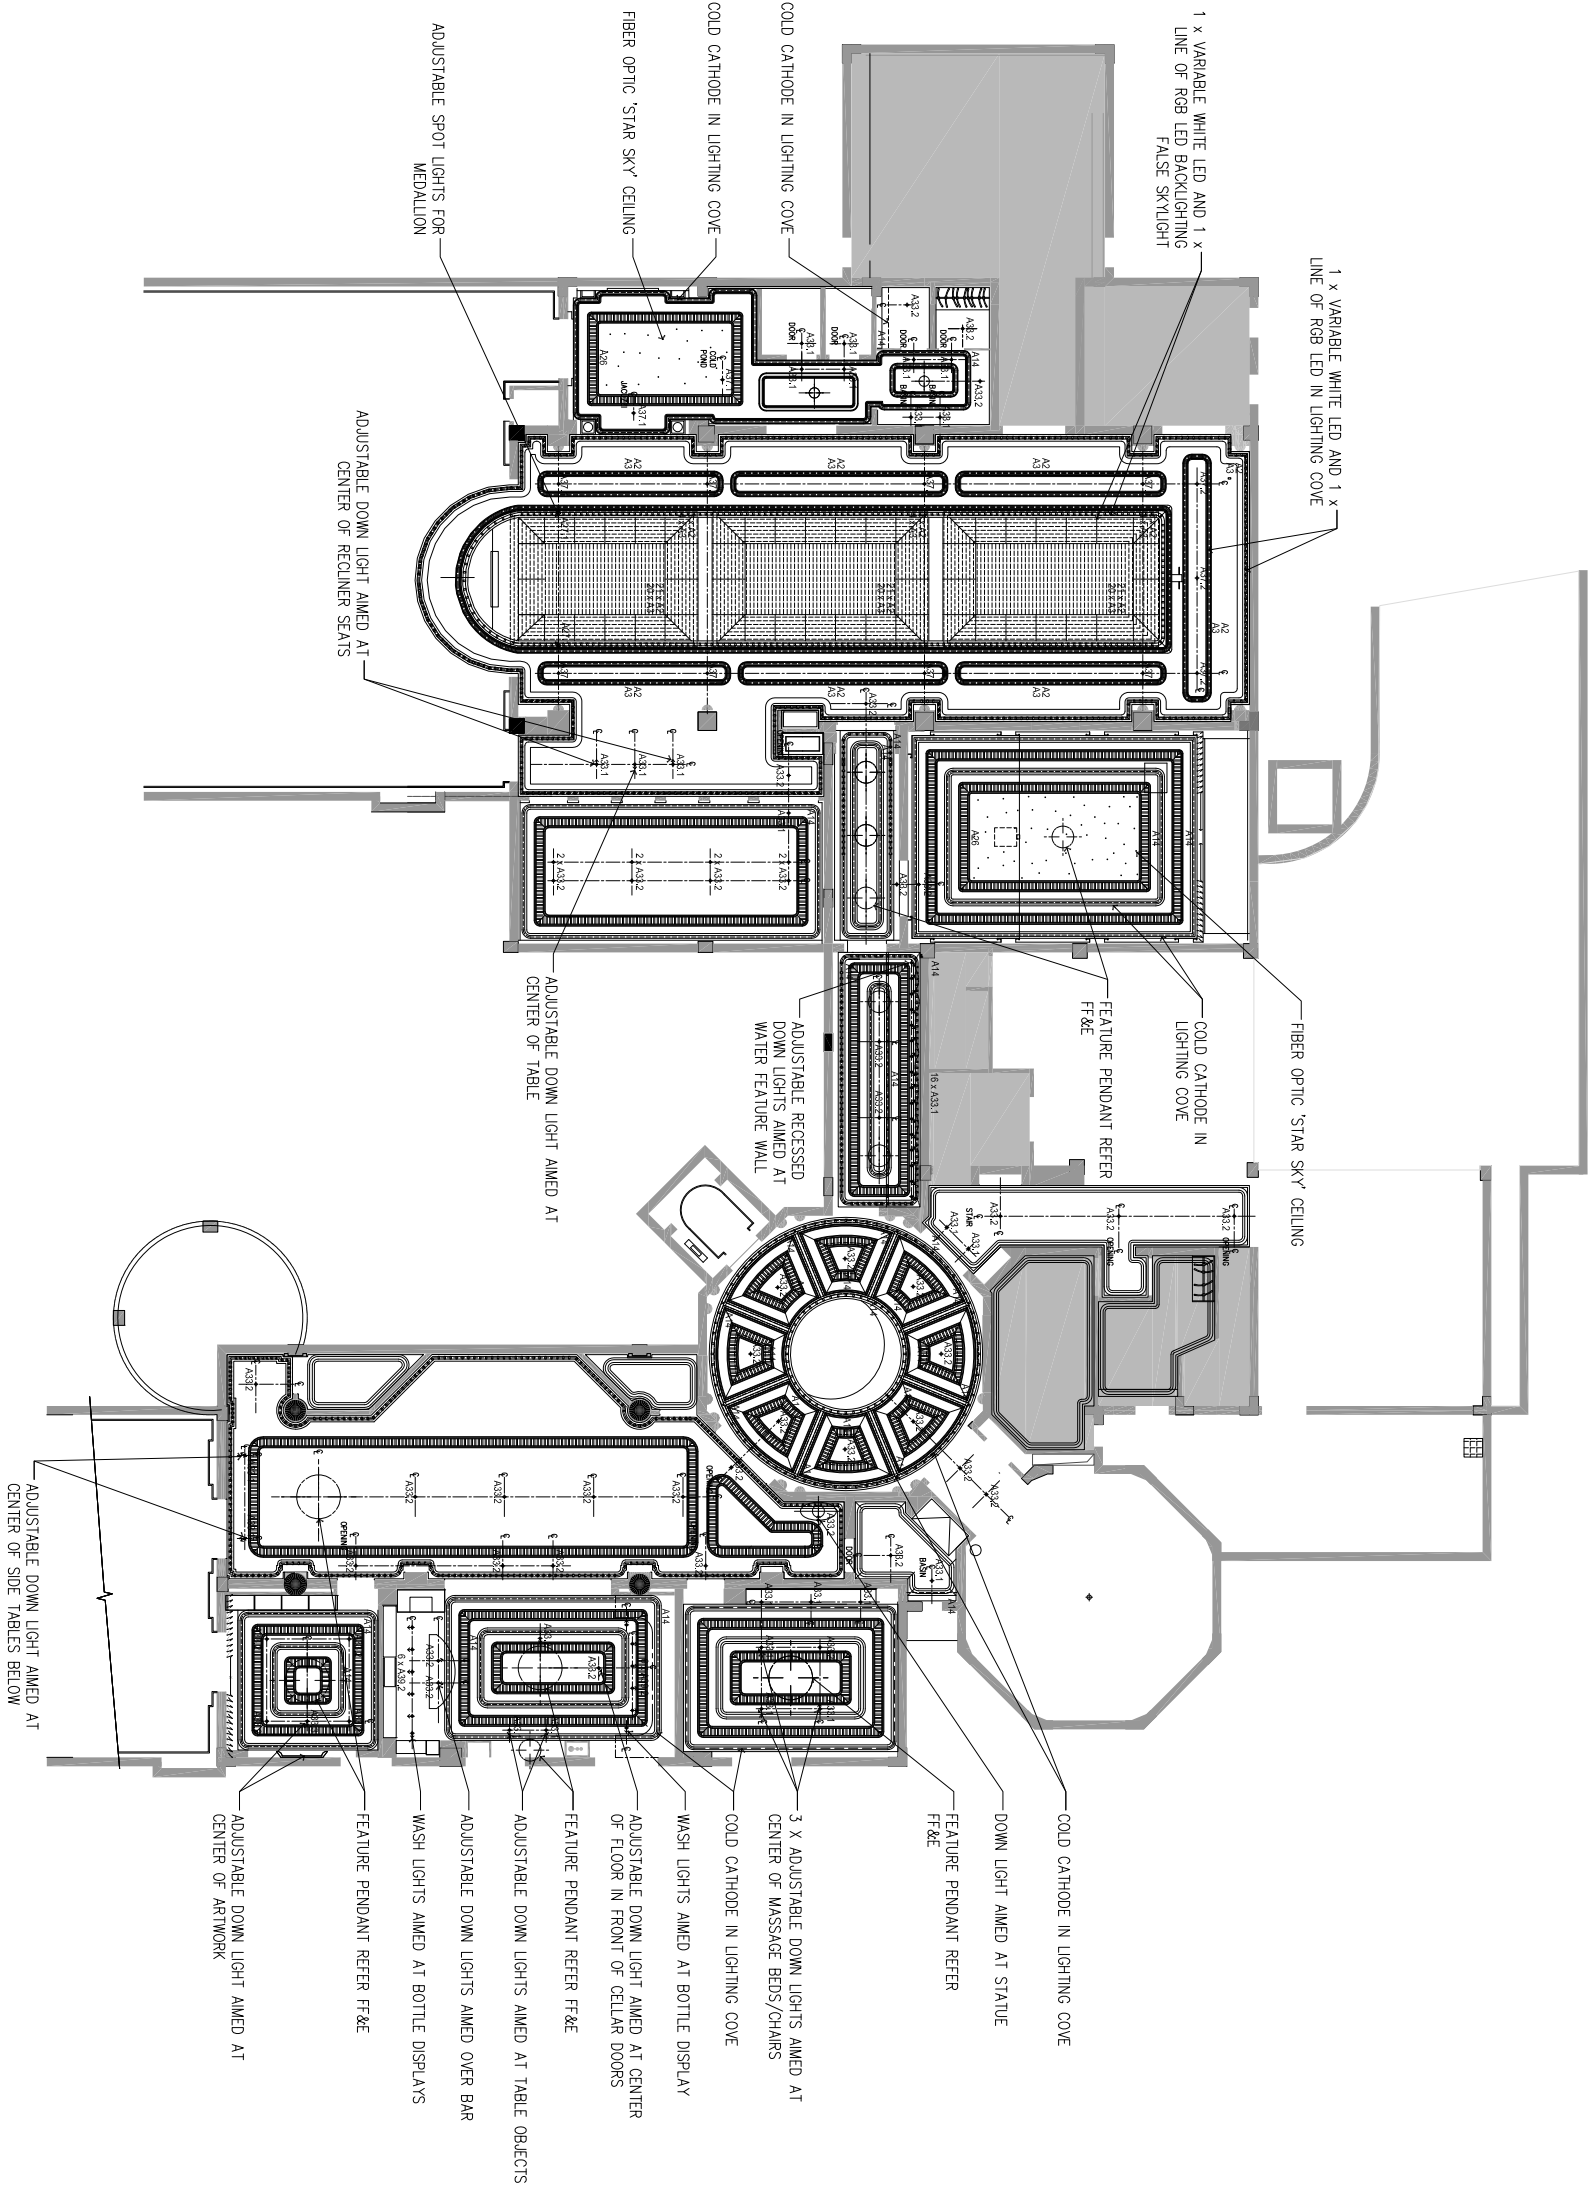

*ALL ADJUSTABLE LIGHT
FITTINGS AND LIGHTING
SCENE LEVELS REQUIRE
COMMISSIONING BY
LIGHTING DESIGNER
所有可调节的灯光和照明场景需要调试灯光设计师

4.2
01 BASEMENT – REFLECTED CEILING LIGHTING PLAN
Scale 1:100@A2