



HBA
WWW.HBADESIGN.COM

NINGBO VILLA
CHINA


REVISIONS DATE

SECOND FLOOR
REFLECTED CEILING LIGHTING LAYOUT

DRAWING TITLE
DRAWN BY
DATE 11/08/2011
SCALE 1:100@A2

APPROVED
DATE 11/08/2011
SCALE 1:100@A2

SHEET No.
LD1-2.2
PROJECT No.
2816.80

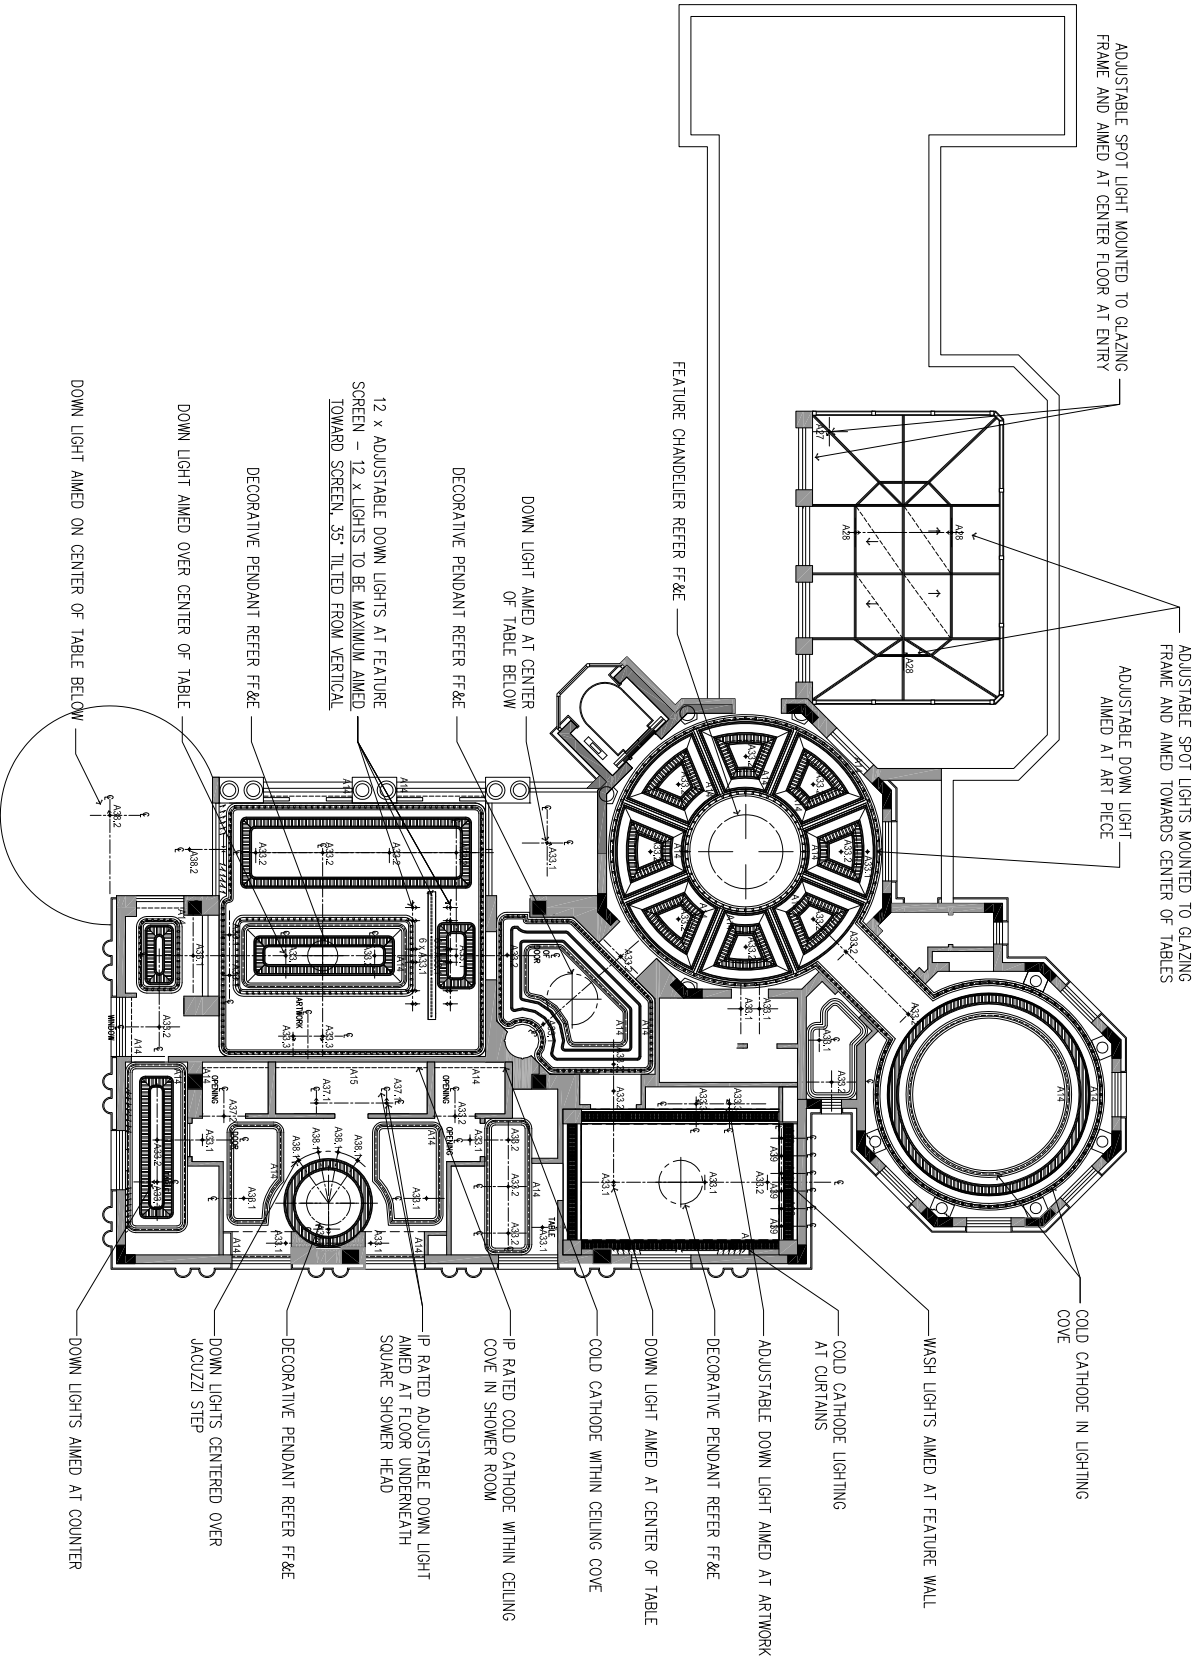

ADJUSTABLE SPOT LIGHT MOUNTED TO GLAZING FRAME AND AIMED AT CENTER FLOOR AT ENTRY

ADJUSTABLE SPOT LIGHTS MOUNTED TO GLAZING FRAME AND AIMED TOWARDS CENTER OF TABLES

ADJUSTABLE DOWN LIGHT AIMED AT ART PIECE

FEATURE CHANDELIER REFER FF&E

DOWN LIGHT AIMED AT CENTER OF TABLE BELOW

DECORATIVE PENDANT REFER FF&E

12 x ADJUSTABLE DOWN LIGHTS AT FEATURE SCREEN - 12 x LIGHTS TO BE MAXIMUM AIMED TOWARD SCREEN, 35° TILTED FROM VERTICAL

DECORATIVE PENDANT REFER FF&E

DOWN LIGHT AIMED OVER CENTER OF TABLE

DOWN LIGHT AIMED ON CENTER OF TABLE BELOW

COLD CATHODE LIGHTING AT CURTAINS

WASH LIGHTS AIMED AT FEATURE WALL

COLD CATHODE IN LIGHTING COVE

ADJUSTABLE DOWN LIGHT AIMED AT ARTWORK

DECORATIVE PENDANT REFER FF&E

DOWN LIGHT AIMED AT CENTER OF TABLE

COLD CATHODE WITHIN CEILING COVE

DOWN LIGHT AIMED AT CENTER OF TABLE

IP RATED COLD CATHODE WITHIN CEILING COVE IN SHOWER ROOM

IP RATED ADJUSTABLE DOWN LIGHT AIMED AT FLOOR UNDERNEATH SQUARE SHOWER HEAD

DECORATIVE PENDANT REFER FF&E

DOWN LIGHTS CENTERED OVER JACUZZI STEP

DOWN LIGHTS AIMED AT COUNTER

2.2 SECOND FLOOR - REFLECTED CEILING LIGHTING PLAN
01 Scale 1:100@A2

FOR INFORMATION
DATE:11 AUGUST 2011

HIRSCH BEDNER ASSOCIATES ■ DESIGN CONSULTANTS ■ GROUND FLOOR 44 OXFORD ST. COLLINGWOOD,VIC AUSTRALIA +61394183500

*ALL ADJUSTABLE LIGHT FITTINGS AND LIGHTING SCENE LEVELS REQUIRE COMMISSIONING BY LIGHTING DESIGNER
所有可调节的灯光和照明场景需要调试灯光设计师

© COPYRIGHT BY HIRSCH/BEDNER AND ASSOCIATES ALL RIGHTS RESERVED.