



HBA
WWW.HBADESIGN.COM

NINGBO VILLA
CHINA


REVISIONS DATE

THIRD FLOOR
LOW LEVEL LIGHTING LAYOUT

DRAWING TITLE
DRAWN BY
DATE 11/08/2011
SCALE 1:100@A2

APPROVED
DATE 11/08/2011
SCALE 1:100@A2

SHEET No.
LD1-3.1
PROJECT No.
2816.80

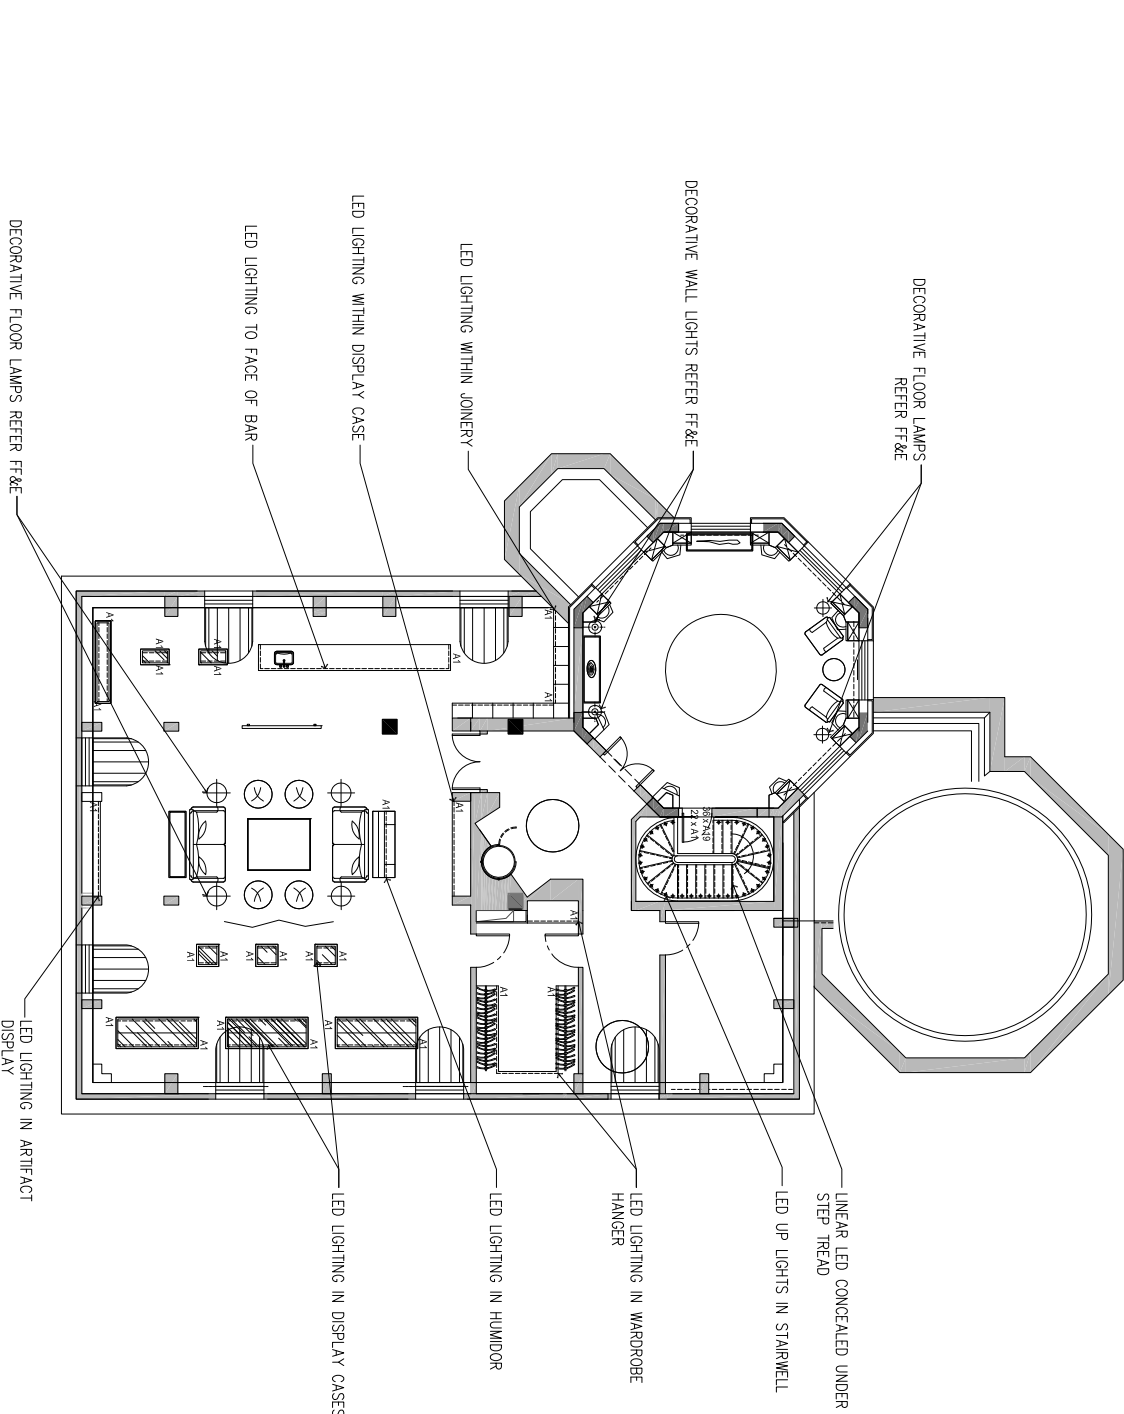

3.1
01
THIRD FLOOR – LOW LEVEL LIGHTING LAYOUT
Scale 1:100@A2

*ALL ADJUSTABLE LIGHT
FITTINGS AND LIGHTING
SCENE LEVELS REQUIRE
COMMISSIONING BY
LIGHTING DESIGNER
所有可调节的灯光和照明场景需要调试灯光设计师