


所有可调节的灯光和照明场景需要调试灯光设计师

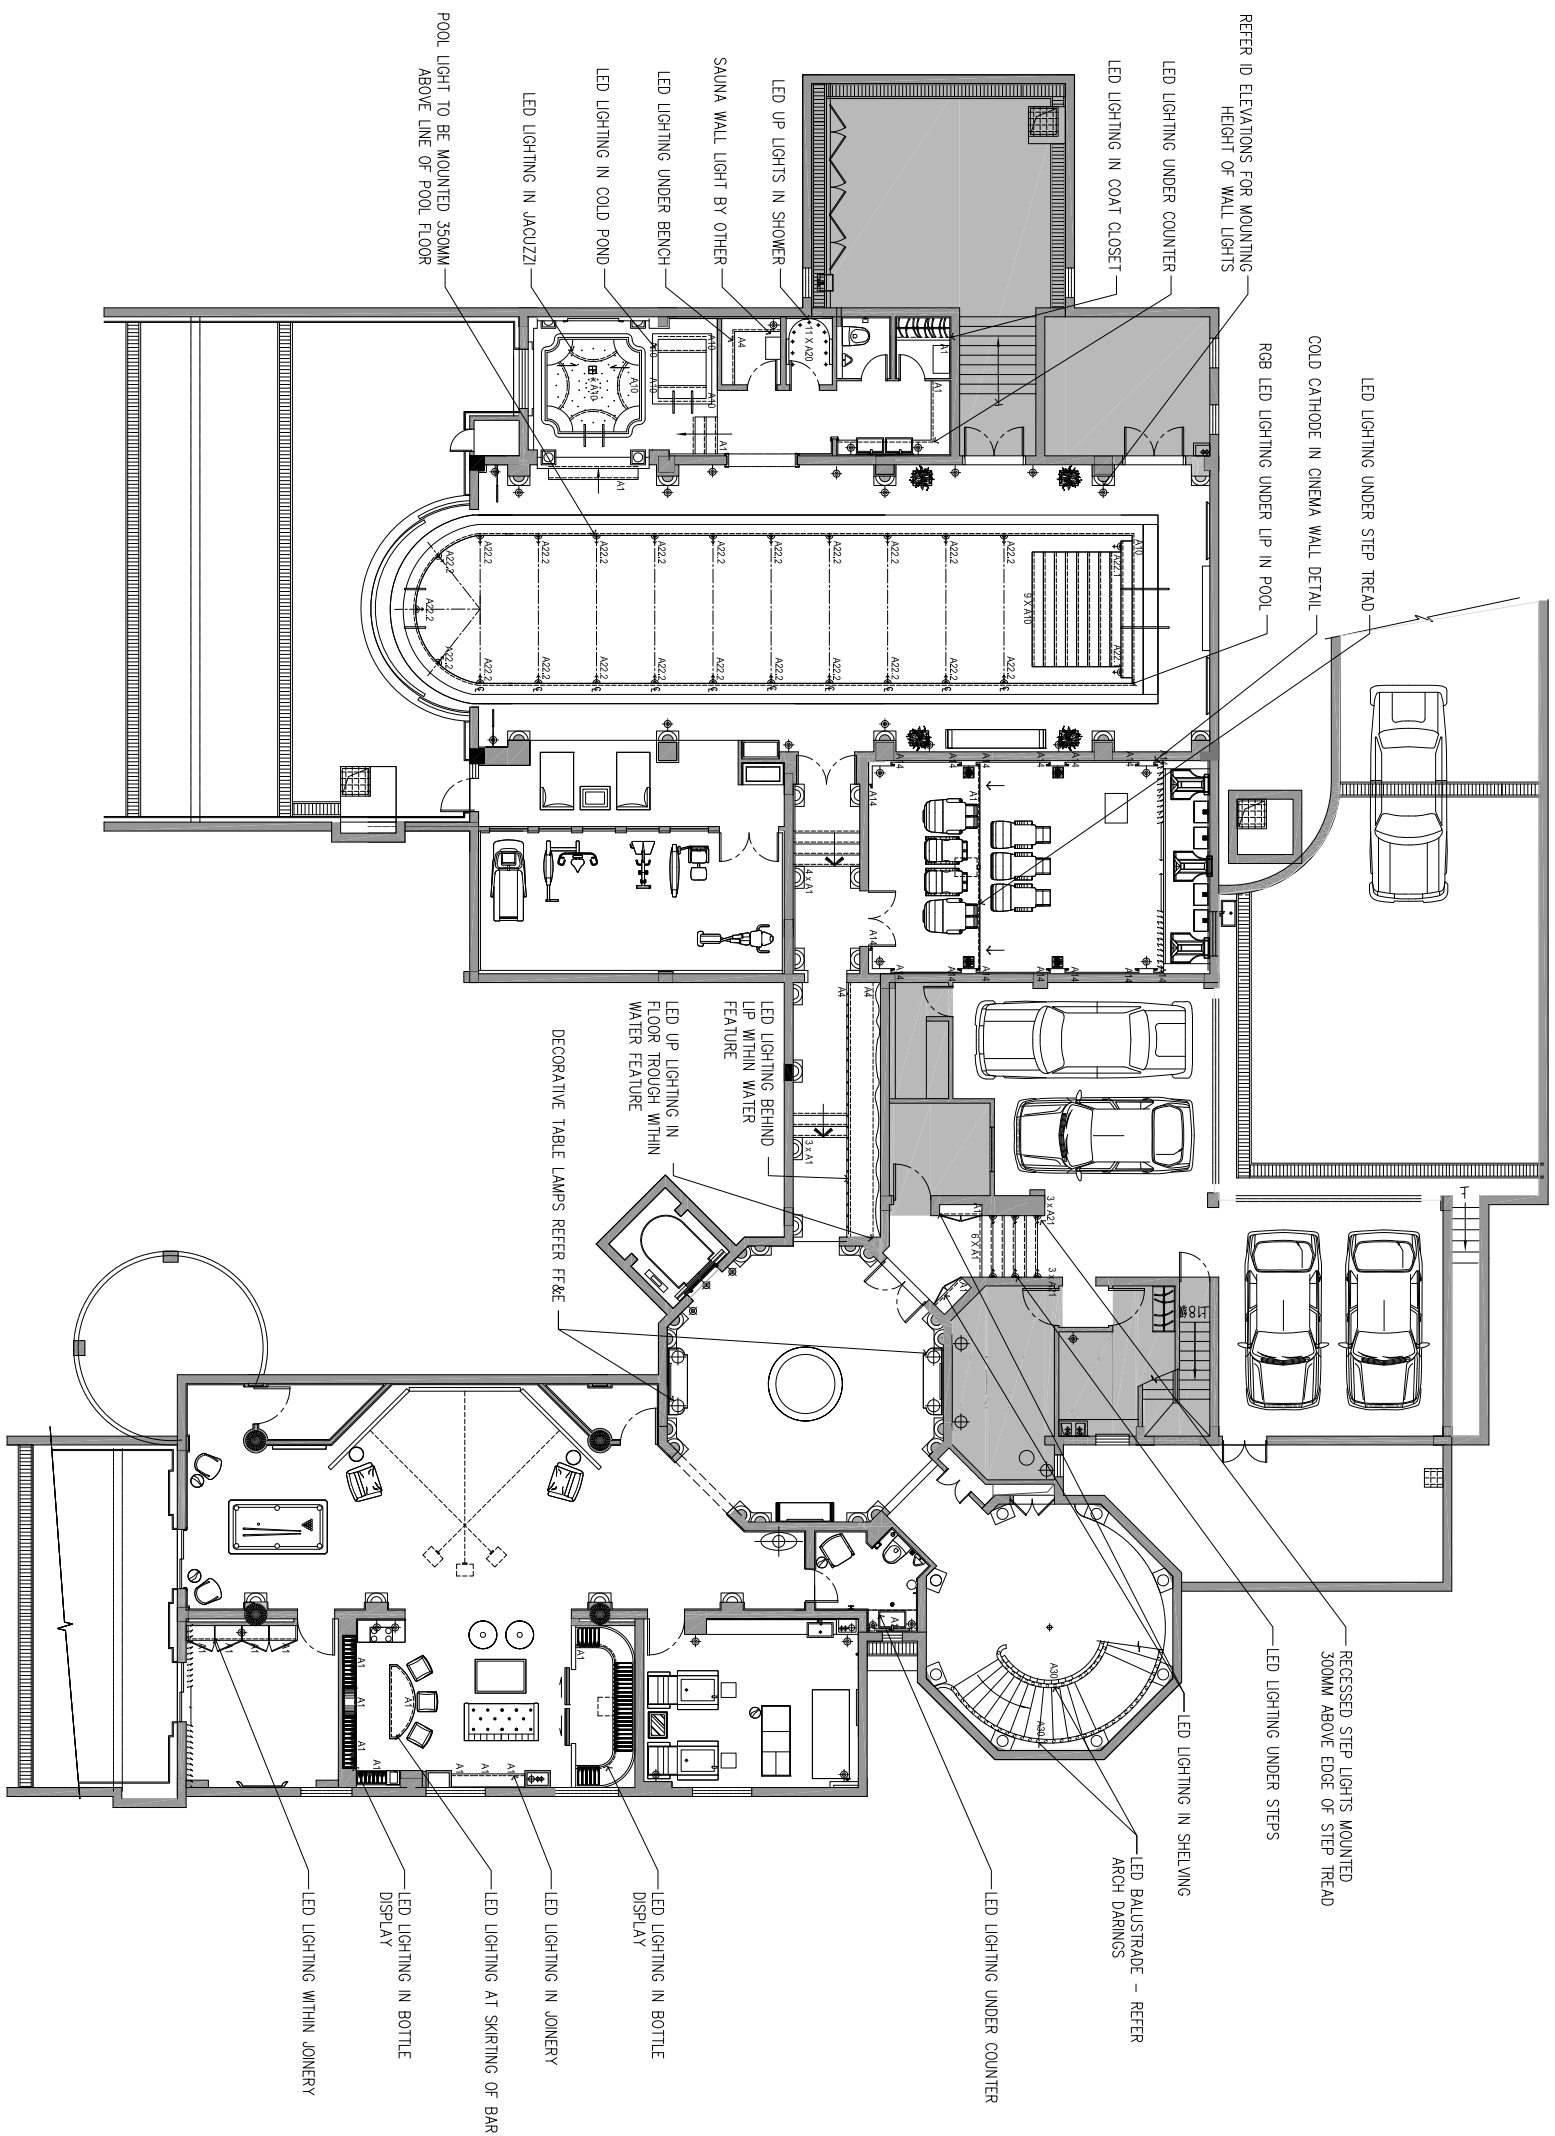

4.1  
01

BASEMENT - LOW LEVEL LIGHTING PLAN

Scale 1:100@A2

FOR INFORMATION  
DATE: 11 AUGUST 2011

■ HIRSCH BEDNER ASSOCIATES ■ DESIGN CONSULTANTS ■ GROUND FLOOR 44 OXFORD ST. COLLINGWOOD, VIC AUSTRALIA +61394183500 ■



HBA  
www.hbadesign.com

NINGBO VILLA  
CHINA

 REVISIONS	DATE

BASEMENT FLOOR  
LOW LEVEL LIGHTING LAYOUT

# TITLE

This drawing is for information only to be used by the contractor as a general arrangement of relative dimensions. It has been made from available information, however measurements are to be verified on project site. This drawing must be verified and approved prior to final detailing and fabrication.

This drawing is the property of HEBICH BENRER AND ASSOCIATES and it is not to be reproduced or copied in whole or in part. It is only to be used for the project and the specifically identified herein and is not to be used on any other project. It is to be returned upon request.

APPROVED

DRAWN BY

DATE 11/08/2011

SHEET No. \_\_\_\_\_

LD1-4.1  
PROJECT No.

2816.80