


**\*ALL ADJUSTABLE LIGHT  
FITTINGS AND LIGHTING  
SCENE LEVELS REQUIRE  
COMMISSIONING BY  
LIGHTING DESIGNER**

3.2  
01

THIRD FLOOR - REFLECTED CEILING LAYOUT

Scale 1:100@A2

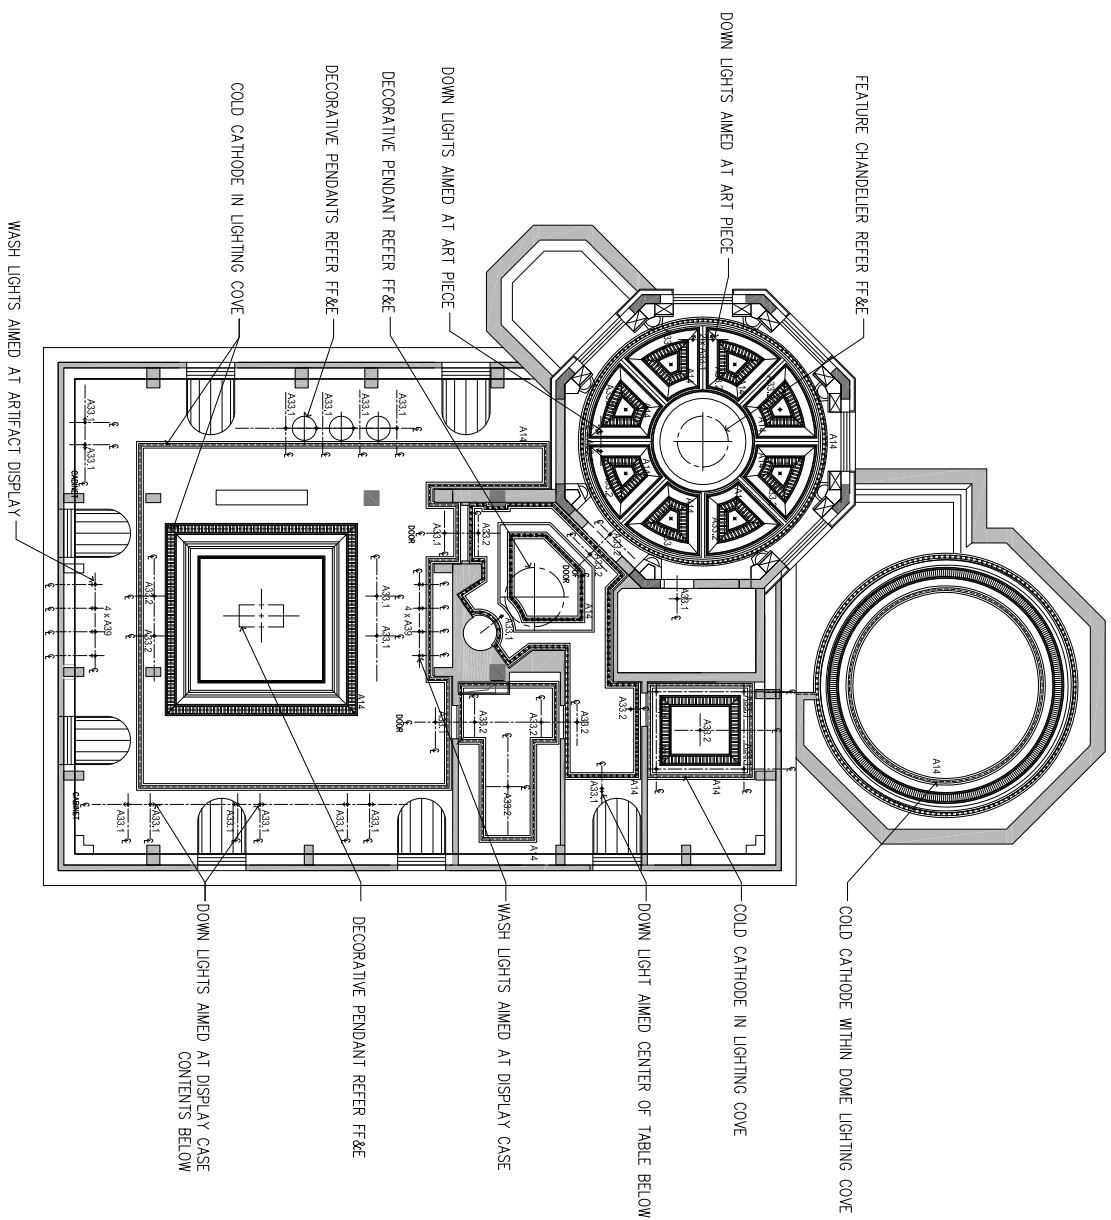

NOTE: EM/LIGHTING CONSULTANT TO WORK CLOSELY WITH MUSEUM CONSULTANT FOR APPROPRIATE DISPLAY UNIT LIGHTING

FOR INFORMATION  
DATE: 11 AUGUST 2011



HBA  
www.hbadesign.com

NINGBO VILLA  
CHINA

REVISIONS DATE

THIRD FLOOR

REFLECTED CEILING LIGHTING LAYOUT

DRAWING TITLE

This drawing is for information only to be used by the contractors as a general arrangement of relative conditions. It has been made from on-orbitable information, however measurements are to be verified on project site. This drawing shall be verified and approved prior to final detailing and fabrication.

This drawing is the property of HATCH BENTLEY AND ASSOCIATES and is not to be reproduced or used in whole or in part. It is only to be used for the project and not for any other project. It is to be returned upon request.

APPROVED

DRAWN BY

DATE 11/08/2011  
SCALE 1:100@A2

SHEET No.

LD1-3.2  
PROJECT No.

PROJECT No.  
2816.80