

LIGHTING INSTRUMENT KEY | 燈具概要

LOCATION 位置	TYPE 代號	DESCRIPTION 簡介
CEILING RECESSED	A26	"STAR SKY" FIBER OPTIC RGB LED KIT
	A33	RECESSED DOWN LIGHT ROUND TRIMLESS
	A37	RECESSED DOWN LIGHT ROUND TRIMLESS IP RATED
	A38	RECESSED DOWN LIGHT ROUND IP RATED WITH TRIM
	A39	RECESSED WASH LIGHT ROUND, TRIMLESS
	A42	RECESSED LENS WALL WASHER SMALL 21W
	A43	RECESSED LENS WALL WASHER LARGE 28W
BUILT-IN FURNITURE	A1	LINEAR LED WARM WHITE
	A2	LINEAR LED RGB
	A3	LINEAR LED VARIABLE WHITE (WARM TO AMBER)

REMARKS: 注意

1. FOR GENERAL NOTES PLEASE REFER TO LIGHTING SPECIFICATION.

所有關於燈光的注解都能在燈具規格說明書中。

2. THE LIGHTING LAYOUT AND THE CONTROL SCHEDULE ARE ISSUED TO SHOW THE DESIGN INTENT OF THE LIGHTING CONTROL ZONES, ADDITIONAL ZONES, SUCH AS FOR EMERGENCY LIGHTING, ARE NOT INDICATED HEREIN. REFER TO THE EBM CONSULTANT'S DRAWINGS FOR ADDITIONAL INFORMATION REGARDING FIXTURE LOCATIONS, TYPES, QUANTITIES AND CIRCUITING.

3. ALL INSTALLATION ARRANGEMENT OF ALL RELEVANT EQUIPMENT / MATERIAL AS SHOWN ON THE DRAWINGS ARE FOR INDICATIVE PURPOSES ONLY, EXACT LOCATIONS ARE TO BE COORDINATED ON SITE.


4. PAINT ALL LIGHT COVERS OR GORGE IN WHITE OR IN SPECIFIED COLOR BEFORE INSTALLATION
安裝燈具前將所有燈槽塗以白色或指定的顏色。

5. FOR DETAIL SPECIFICATION CONCERNING LAMP SOURCE, WATTAGE, ANGLE, ETC. PLEASE CHECK AGAINST LIGHTING SPECIFICATION. 關於燈具的詳細說明，光源、瓦數、角度等等。請燈具規格說明書

5.6. CONTRACTOR TO CO-ORDINATE SUITABLE LED CONTROLLER WITH MANUFACTURER, 承包商需與製造商協調該LED適當的控制裝置。

	A4	IP RATED FLEXIBLE LED
	A5	IP RATED LINEAR IN GROUND LED UP LIGHT
	A6	IP RATED FLEXIBLE LED
	A10	IP RATED FLEXIBLE RGB LED
	A14	HIGH OUTPUT COLD CATHODE
	A15	IP RATED HIGH OUTPUT COLD CATHODE
FLOOR	A19	LED IN GROUND UP LIGHT STAIRWELL
	A20	LED IN GROUND UP LIGHT SHOWER
WALL AND OTHER	A21	RECESSED WALL LIGHT LED
	A22	RECESSED POOL LIGHT
	A23	RECESSED LED UP LIGHT
	A27	SURFACE MOUNTED SPOT LIGHT

KEY | 圖解

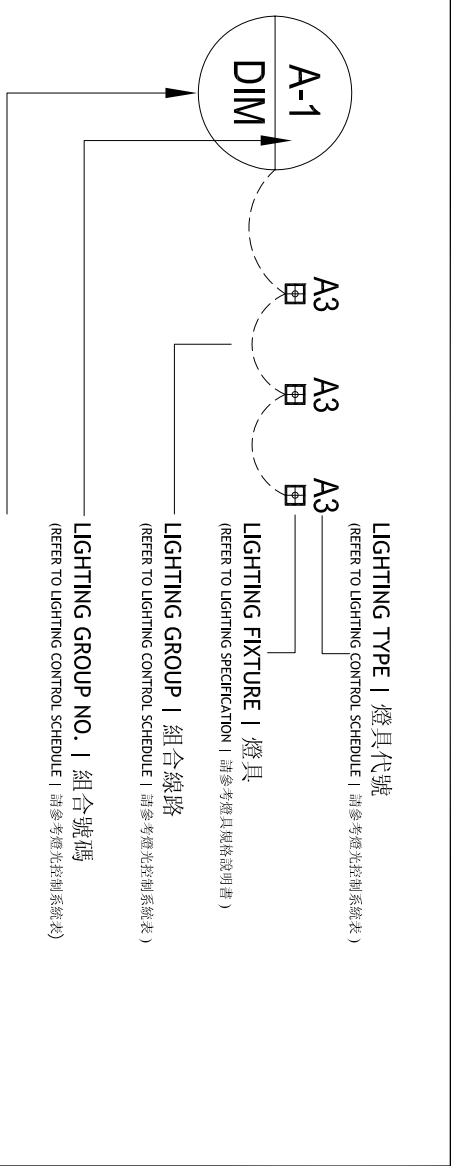

A29	GARDEN SPIKE LIGHT
A30	LED BALUSTRADE

圖號名稱 SHEET TITLES

圖紙編號 SHEET No.		內容 DESCRIPTION	出圖日期 RELEASE DATE	修正 REVISIONS
NINGBO WILLA – LIGHTING LAYOUTS				
LD-00	COVER		11/08/11	1
LD-01	LIGHTING LEGEND		11/08/11	1
LD-41	BASEMENT – LOW LEVEL PLAN – LIGHTING LAYOUT		11/08/11	1
LD-41.1	BASEMENT – LOW LEVEL PLAN – GROUPING LAYOUT	-		
LD-42	BASEMENT – REFLECTED CEILING PLAN – LIGHTING LAYOUT	11/08/11	1	
LD-42.1	BASEMENT – REFLECTED CEILING PLAN – GROUPING LAYOUT	-		
LD-01	GROUND FLOOR – LOW LEVEL PLAN – LIGHTING LAYOUT		11/08/11	1
LD-01.1	GROUND FLOOR – LOW LEVEL PLAN – GROUPING LAYOUT	-		
LD-02	GROUND FLOOR – REFLECTED CEILING PLAN – LIGHTING LAYOUT	11/08/11	1	
LD-02.1	GROUND FLOOR – REFLECTED CEILING PLAN – GROUPING LAYOUT	-		
LD-11	LEVEL 1 – LOW LEVEL PLAN – LIGHTING LAYOUT		11/08/11	1
LD-11.1	LEVEL 1 – LOW LEVEL PLAN – GROUPING LAYOUT	-		
LD-12	LEVEL 1 – REFLECTED CEILING PLAN – LIGHTING LAYOUT	11/08/11	1	
LD-12.1	LEVEL 1 – REFLECTED CEILING PLAN – GROUPING LAYOUT	-		
LD-21	LEVEL 2 – LOW LEVEL PLAN – LIGHTING LAYOUT		11/08/11	1
LD-21.1	LEVEL 2 – LOW LEVEL PLAN – GROUPING LAYOUT	-		
LD-22	LEVEL 2 – REFLECTED CEILING PLAN – LIGHTING LAYOUT	11/08/11	1	
LD-22.1	LEVEL 2 – REFLECTED CEILING PLAN – GROUPING LAYOUT	-		
LD-31	LEVEL 3 – LOW LEVEL PLAN – LIGHTING LAYOUT		11/08/11	1
LD-31.1	LEVEL 3 – LOW LEVEL PLAN – GROUPING LAYOUT	-		
LD-32	LEVEL 3 – REFLECTED CEILING PLAN – LIGHTING LAYOUT	11/08/11	1	
LD-32.1	LEVEL 3 – REFLECTED CEILING PLAN – GROUPING LAYOUT	-		
AUXILIARY DOCUMENTS		輔助文件		
LD2-1	LIGHTING SPECIFICATION	燈具規格說明書	11/08/11	1
LD2-2	LIGHTING CONTROL SCHEDULE	燈光控制系統表	-	
修正日期 REVISION DATES		修正日期 REVISION DATES	11/08/11	

*ALL ADJUSTABLE LIGHT
FITTINGS AND LIGHTING
SCENE LEVELS REQUIRE
COMMISSIONING BY
LIGHTING DESIGNER

FOR INFORMATION
DATE: 11 AUGUST 2011

修正日期	REVISION	DATES
修正日期	REVISION	DATES

11/08/11



IBA

NINGBO VILLA
CHINA

REVISIONS

TITLE

THIRD FLOOR

LIGHTING LEGEND

This drawing is the property of HERSCO RESEARCH AND ASSOCIATES, and is not to be reproduced or copied in whole or in part. It may be used for the project only and is not to be used for any other project. It is not to be specifically identified with HERSCO and is not to be used on any other project. It is to be returned upon request.

APPROVED

DRAWN BY

SCALE 1:100 @A2

SHEET No.

LD-0
PROJECT No.
2816.80