


LIGHTING INSTRUMENT KEY | 燈具概要

LOCATION 位置	TYPE 代號	DESCRIPTION 簡介
CEILING RECESSED	A26	"STAR SKY" FIBER OPTIC RGB LED KIT
	A33	RECESSED DOWN LIGHT ROUND TRIMLESS
	A37	RECESSED DOWN LIGHT ROUND TRIMLESS IP RATED
	A38	RECESSED DOWN LIGHT ROUND IP RATED WITH TRIM
	A39	RECESSED WASH LIGHT ROUND, TRIMLESS
	A42	RECESSED LENS WALL WASHER SMALL 21W
	A43	RECESSED LENS WALL WASHER LARGE 28W
	A1	LINEAR LED WARM WHITE
	A2	LINEAR LED RGB
	A3	LINEAR LED VARIABLE WHITE (WARM TO AMBER)
	A4	IP RATED FLEXIBLE LED
	A5	IP RATED LINEAR IN GROUND LED UP LIGHT
	A6	IP RATED FLEXIBLE LED
	A10	IP RATED FLEXIBLE RGB LED
	A14	HIGH OUTPUT COLD CATHODE
	A15	IP RATED HIGH OUTPUT COLD CATHODE
FLOOR	A19	LED IN GROUND UP LIGHT STAIRWELL
	A20	LED IN GROUND UP LIGHT SHOWER
	A21	RECESSED WALL LIGHT LED
	A22	RECESSED POOL LIGHT
WALL AND OTHER	A23	RECESSED LED UP LIGHT
	A27	SURFACE MOUNTED SPOT LIGHT

KEY | 圖解

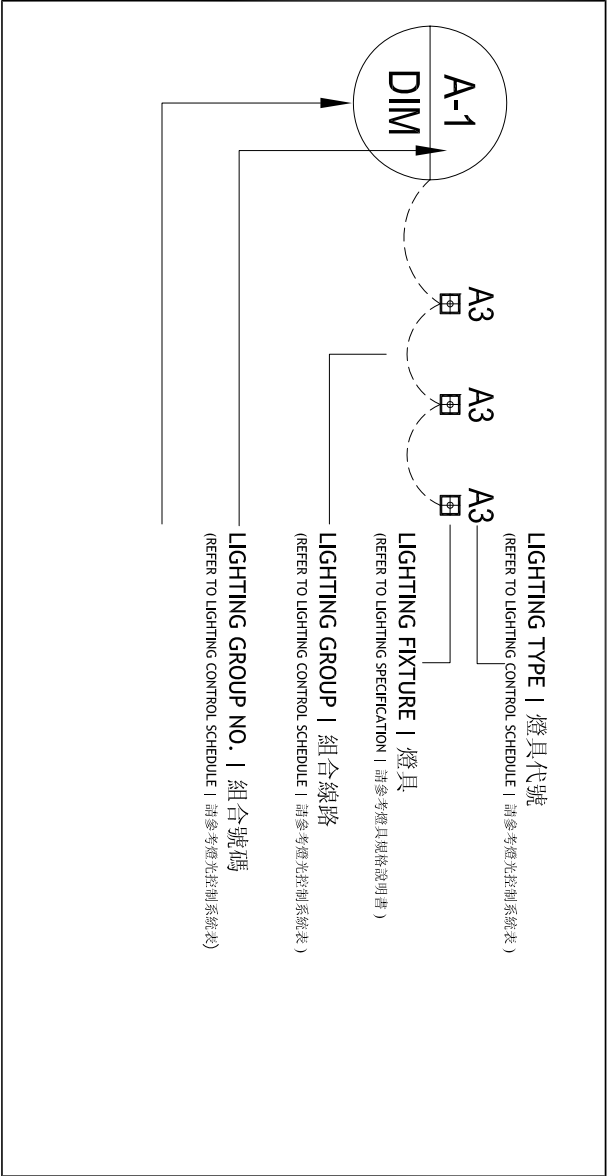

A29 GARDEN SPIKE LIGHT
A30 LED BALUSTRADE

- REMARKS: 注意
- FOR GENERAL NOTES PLEASE REFER TO LIGHTING SPECIFICATION.
所有關於燈光的注解都能在燈具規格說明書中。
 - THE LIGHTING LAYOUT AND THE CONTROL SCHEDULE ARE ISSUED TO SHOW THE DESIGN INTENT OF THE LIGHTING CONTROL ZONES, ADDITIONAL ZONES, SUCH AS FOR EMERGENCY LIGHTING, ARE NOT INDICATED HEREIN. REFER TO THE E&M CONSULTANT'S DRAWINGS FOR ADDITIONAL INFORMATION REGARDING FIXTURE LOCATIONS, TYPES, QUANTITIES AND CIRCUITING. 及燈光分組佈局圖用以表示燈光設計意圖。另外的區域，如逃生應急燈等，未在此表示。關於這些設備位置，類型，數量及電路的額外資訊參見機電顧問的圖紙。燈光佈局圖。
 - ALL INSTALLATION ARRANGEMENT OF ALL RELEVANT EQUIPMENT / MATERIAL AS SHOWN ON THE DRAWINGS ARE FOR INDICATIVE PURPOSES ONLY, EXACT LOCATIONS ARE TO BE COORDINATED ON SITE.
 - PAINT ALL LIGHT COVES OR GORGE IN WHITE OR IN SPECIFIED COLOR BEFORE INSTALLATION.
安裝燈具前將所有燈槽塗以白色或指定的顏色。
 - FOR DETAIL SPECIFICATION CONCERNING LAMP SOURCE, WATTAGE, ANGLE, ETC. PLEASE CHECK AGAINST LIGHTING SPECIFICATION.
關於燈具的詳細說明，光源、瓦數、角度等等，請燈具規格說明書。
 - CONTRACTOR TO CO-ORDINATE SUITABLE LED CONTROLLER WITH MANUFACTURER.

圖號名稱 SHEET TITLES

圖紙編號 SHEET No.	內容 DESCRIPTION	出圖日期 RELEASE DATE	修正 REVISIONS
LD-00	COVER	11/08/11	1
	LIGHTING LEGEND	11/08/11	1
LDI-01	BASEMENT - LOW LEVEL PLAN - LIGHTING LAYOUT	11/08/11	1
LDI-4.1.1	BASEMENT - LOW LEVEL PLAN - GROUPING LAYOUT	-	
LDI-4.2	BASEMENT - REFLECTED CEILING PLAN - LIGHTING LAYOUT	11/08/11	1
LDI-4.2.1	BASEMENT - REFLECTED CEILING PLAN - GROUPING LAYOUT	-	
LDI-0.1	GROUND FLOOR - LOW LEVEL PLAN - LIGHTING LAYOUT	11/08/11	1
LDI-0.1.1	GROUND FLOOR - LOW LEVEL PLAN - GROUPING LAYOUT	-	
LDI-0.2	GROUND FLOOR - REFLECTED CEILING PLAN - LIGHTING LAYOUT	11/08/11	1
LDI-0.2.1	GROUND FLOOR - REFLECTED CEILING PLAN - GROUPING LAYOUT	-	
LDI-1.1	LEVEL 1 - LOW LEVEL PLAN - LIGHTING LAYOUT	11/08/11	1
LDI-1.1.1	LEVEL 1 - LOW LEVEL PLAN - GROUPING LAYOUT	-	
LDI-1.2	LEVEL 1 - REFLECTED CEILING PLAN - LIGHTING LAYOUT	11/08/11	1
LDI-1.2.1	LEVEL 1 - REFLECTED CEILING PLAN - GROUPING LAYOUT	-	
LDI-2.1	LEVEL 2 - LOW LEVEL PLAN - LIGHTING LAYOUT	11/08/11	1
LDI-2.1.1	LEVEL 2 - LOW LEVEL PLAN - GROUPING LAYOUT	-	
LDI-2.2	LEVEL 2 - REFLECTED CEILING PLAN - LIGHTING LAYOUT	11/08/11	1
LDI-2.2.1	LEVEL 2 - REFLECTED CEILING PLAN - GROUPING LAYOUT	-	
LDI-3.1	LEVEL 3 - LOW LEVEL PLAN - LIGHTING LAYOUT	11/08/11	1
LDI-3.1.1	LEVEL 3 - LOW LEVEL PLAN - GROUPING LAYOUT	-	
LDI-3.2	LEVEL 3 - REFLECTED CEILING PLAN - LIGHTING LAYOUT	11/08/11	1
LDI-3.2.1	LEVEL 3 - REFLECTED CEILING PLAN - GROUPING LAYOUT	-	
AUXILIARY DOCUMENTS			
LD2-1	LIGHTING SPECIFICATION	11/08/11	1
LD2-2	LIGHTING CONTROL SCHEDULE	-	
輔助文件 燈具規格說明書 燈光控制系統表			
修正日期 REVISION DATES 修正日期 REVISION DATES			
		11/08/11	

TITLE

NINGBO VILLA
CHINA

REVISIONS



HBA

GROUND FLOOR
LIGHTING KEY

This drawing is for information only to be interpreted as a design document. It is not intended to be used for construction. It is the responsibility of the client to ensure that the design is suitable for the intended use and that the design is not used for any other purpose without the written consent of the designer.

APPROVED

DRAWN BY

DATE 11/08/2011

SCALE 1:100 @A2

SHEET No.

LD-01

PROJECT No.
2816.80