



www.hbadesign.com

REVISIONS DATE

NINGBO VILLA
CHINA


FIRST FLOOR
REFLECTED CEILING LIGHTING LAYOUT

DRAWING TITLE
DRAWN BY
DATE 11/08/2011
SCALE 1:100@A2

APPROVED
DATE 11/08/2011
SCALE 1:100@A2

SHEET No.
LD1-1.2
PROJECT No.
2816.80

HIRSCH BEDNER ASSOCIATES ■ DESIGN CONSULTANTS ■ GROUND FLOOR 44 OXFORD ST. COLLINGWOOD,VIC AUSTRALIA +61394183500

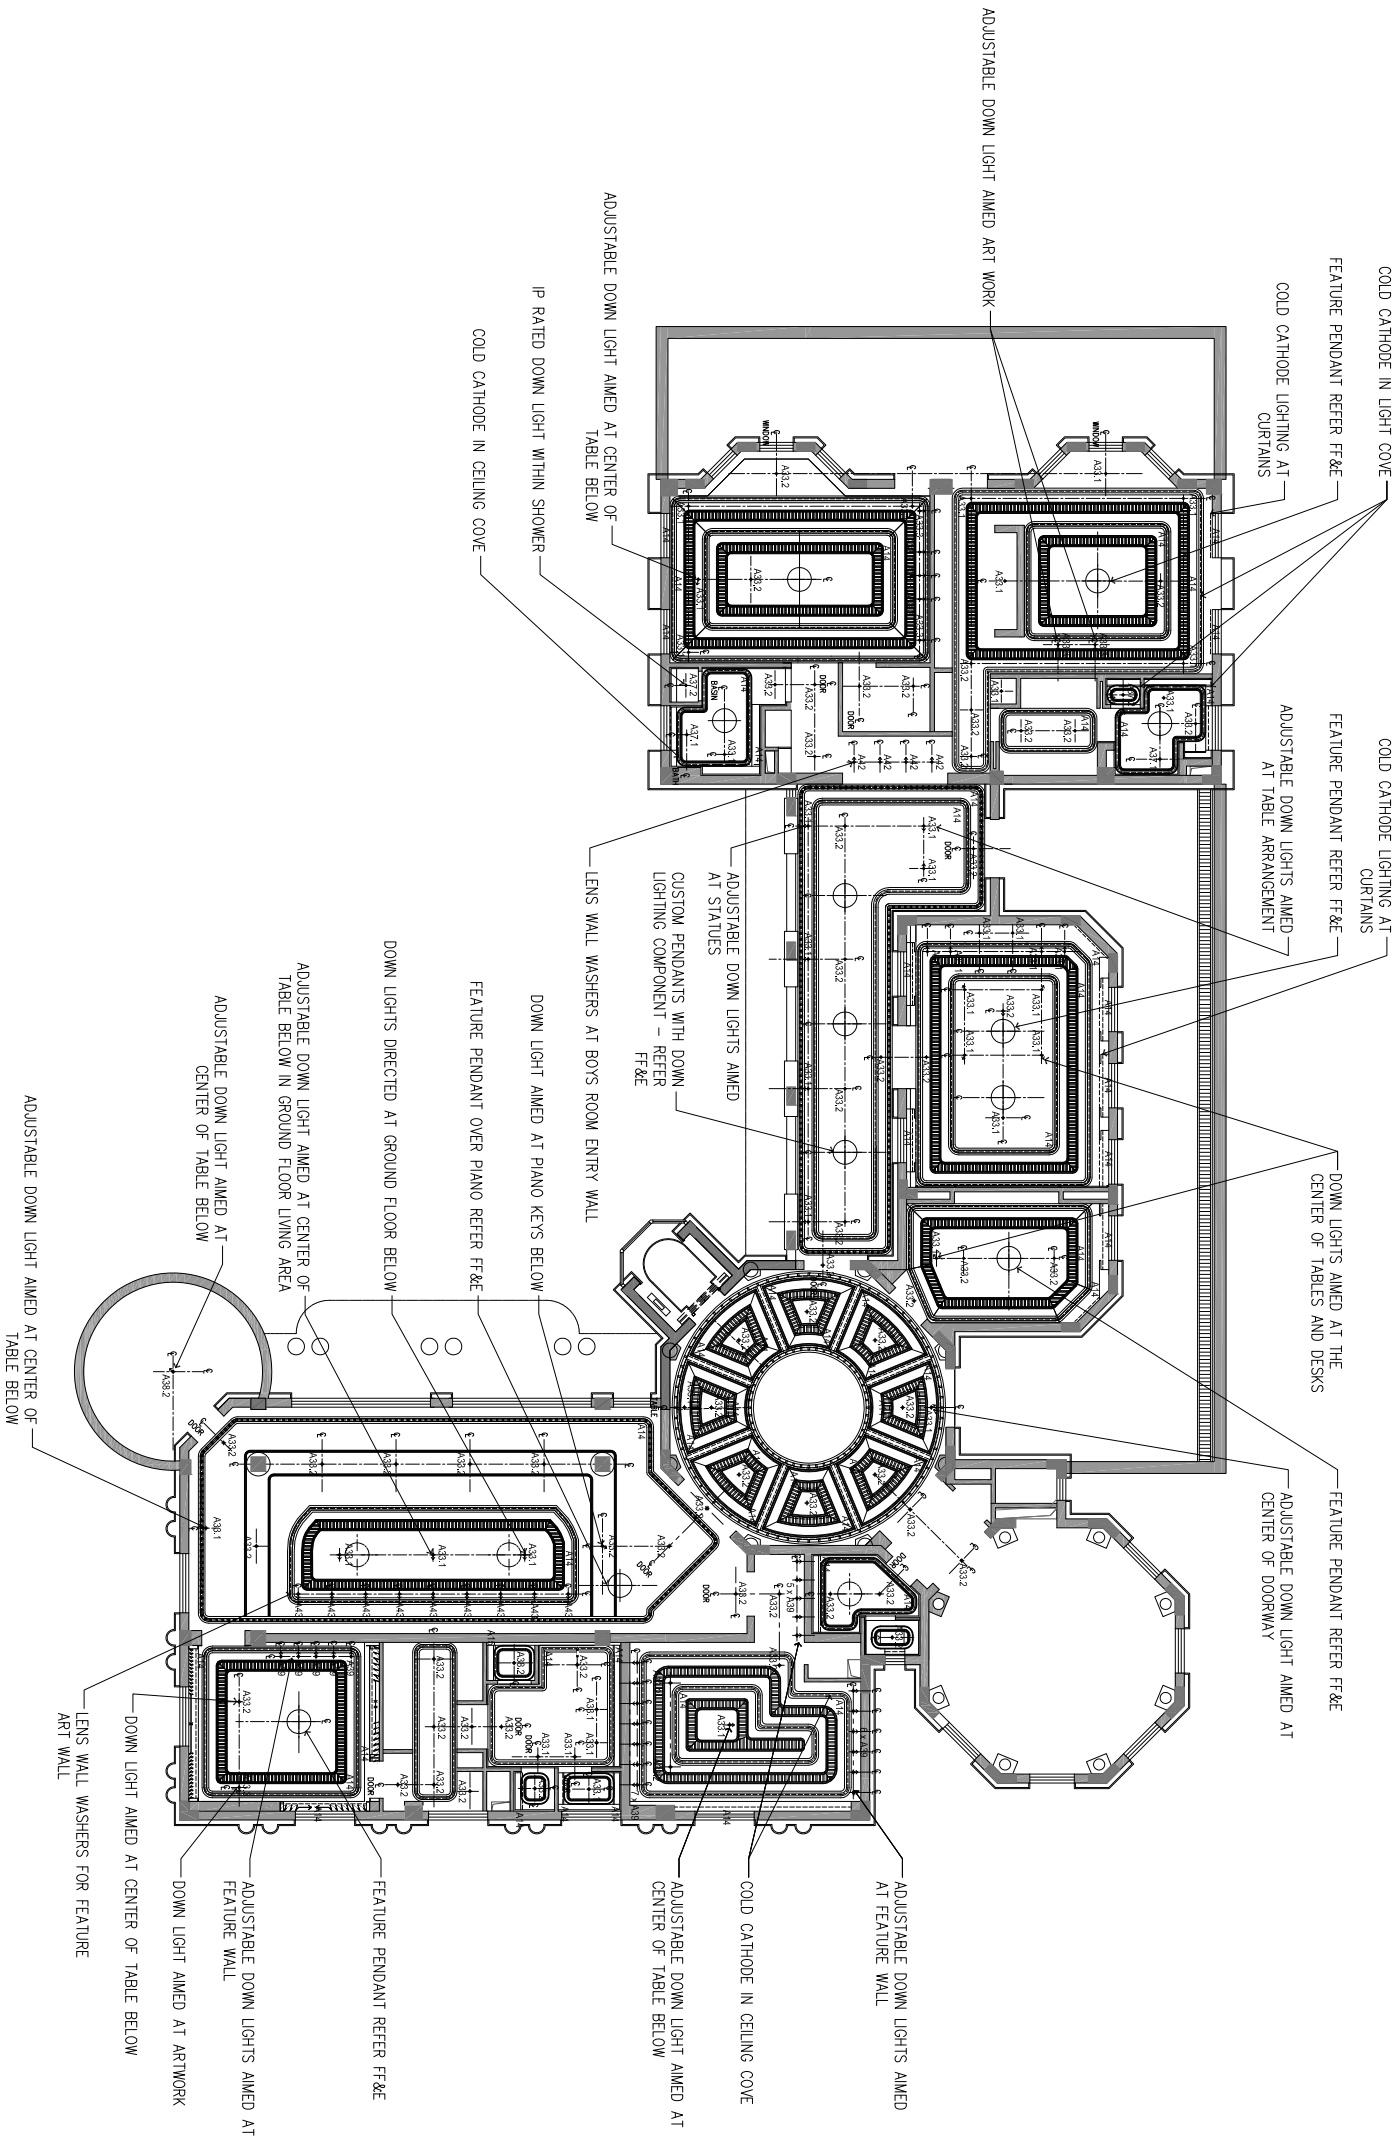

*ALL ADJUSTABLE LIGHT
FITTINGS AND LIGHTING
SCENE LEVELS REQUIRE
COMMISSIONING BY
LIGHTING DESIGNER
所有可调节的灯光和照明场景需要调试灯光设计师

12
01 FIRST FLOOR – REFLECTED CEILING LIGHTING PLAN
Scale 1:100@A2

© COPYRIGHT BY HIRSCH/BEDNER AND ASSOCIATES ALL RIGHTS RESERVED.